



1 PARTIAL BASEMENT ELECTRICAL PLAN
 E1.01 SCALE: 1/4" = 1'-0"

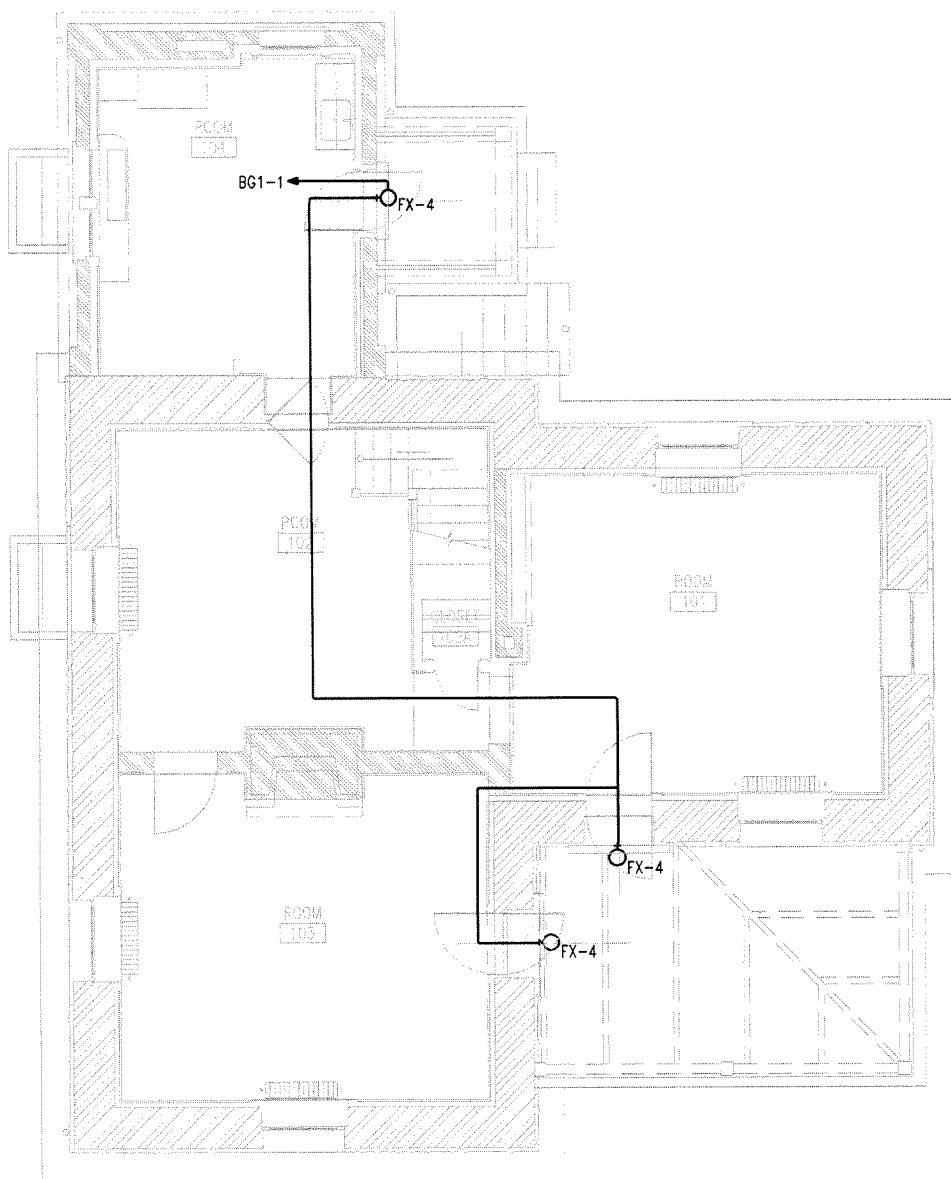


2 FIRST FLOOR LIGHTING PLAN
 E1.01 SCALE: 1/4" = 1'-0"

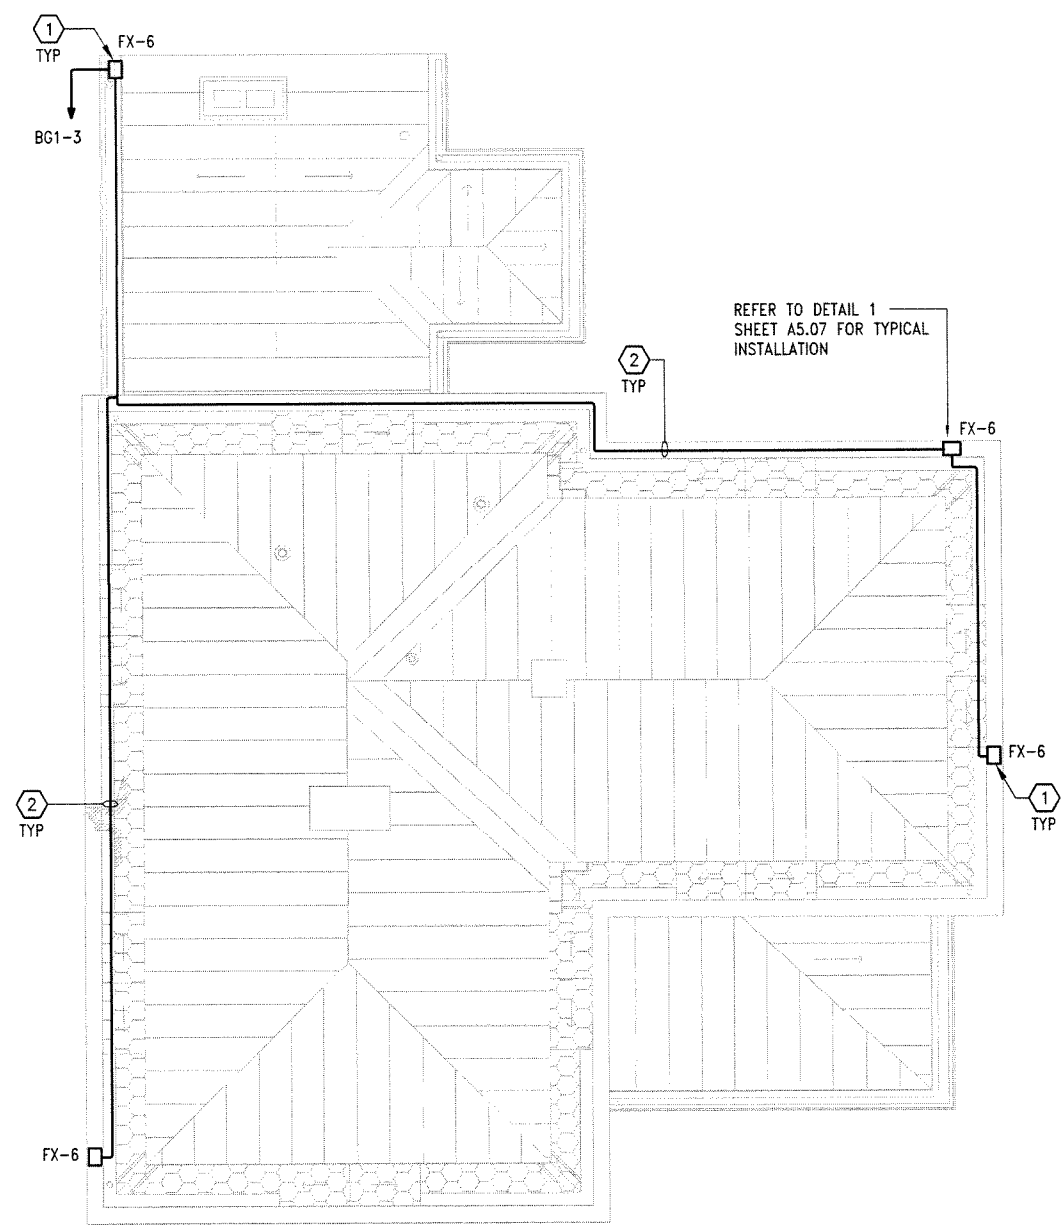

2 ROOF LIGHTING PLAN
 E1.01 SCALE: 1/4" = 1'-0"

- KEYED NOTES**
1. ROOF MOUNTED FIXTURE TYPE "FX-6" PROVIDED WITH MOTION SENSOR. REFER TO FIXTURE SCHEDULE FOR SPECIFICATIONS.
 2. PROVIDE NEW SURFACE MOUNTED CONDUIT FOR ROOF MOUNTED FIXTURES. CONDUIT SHALL BE MOUNTED CLEAR OF GUTTER ON OUTBOARD SIDE OF GUTTER. REFER TO 1/A507.
 3. NEW PANEL AND ELECTRICAL UTILITY METER. RECONNECT ALL EXISTING BRANCH CIRCUITS TO AVAILABLE SPARE DEVICES IN NEW PANEL. PROVIDE ADDITIONAL CONDUCTORS WHERE NECESSARY TO FACILITATE THE RECONNECTION OF EXISTING BRANCH CIRCUITS TO NEW ELECTRICAL PANEL.
 4. NOT USED.
 5. RECONNECT EXISTING BOILER EQUIPMENT AND SUMP PUMP TO NEW PANEL.

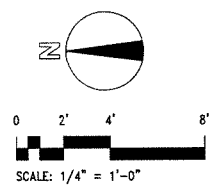

- GENERAL NOTES**
1. REFER TO SHEET E0.01 FOR ELECTRICAL NOTES, SYMBOLS AND ABBREVIATIONS.
 2. COORDINATE WITH STRUCTURAL CONTRACTOR ANY DRILLING DONE TO EXISTING JOISTS.
 3. CONTRACTOR SHALL RECONNECT ANY EXISTING CIRCUITS TO NEW PANEL AS REQUIRED TO MAINTAIN BUILDING IN OPERATIONAL CONDITION.



A/E FIRM	Mark	Sheet	REVISION	Date	Initial
PRIME/ARCH:	△		REVISION-1	10.30.09	
BEYER BLUNDER BELLE ARCHITECTS AND PLANNERS, LLP WASHINGTON, DC					
MEP ENG.:					
GHT CHARTERED ARLINGTON, VA					

E1.01
 SUB SHEET NUMBER

ELECTRICAL BASEMENT 1ST FLOOR & ROOF LIGHTING PLANS
 TITLE OF DRAWING

UNITED STATES DEPARTMENT OF THE INTERIOR
 NATIONAL PARK SERVICE - NATIONAL CAPITAL REGION
 BRANCH OF DESIGN AND CONSTRUCTION
 REHABILITATE DETERIORATED BATTLEGROUND NATIONAL CEMETERY SUPERINTENDENT'S LODGE AND ROSTRUM
 TITLE OF PROJECT
 6625 GEORGIA AVE NW, WASHINGTON, DC
 LOCATION WITHIN PARK
 ROCK CREEK PARK
 NAME OF PARK

DESIGNED	SCB
DRAWN	FJB
CHECKED	
NO. NO.	858
DATE	APR. 24, 2009
SHEET	34 OF 34